



Your Ref: **1178750**
Our Ref: **PSUS-1535236.1**
Date: 04 Sep 2018

CHRIS KITSON
YORK PLACE COMPANY SERVICES
LOWER GROUND FLOOR
ONE GEORGE YARD
LONDON

EC3V 9DF

[PSUS-1535236.1]



Plant Protection
Cadent
Block 1
Brick Kiln Street
Hinckley
LE10 0NA

Telephone 0800 688588*
Email: plantprotection@cadentgas.com

Electricity Emergency Number:
0800 40 40 90*
National Gas Emergency Number:
0800 111 999*

*Available 24 hours, 7 days/week.
Calls may be recorded and monitored.
www.cadentgas.com

F.A.O. Chris Kitson

Dear Sirs,

Re: 13-15 CINNAMON STREET, LONDON, E1W 3NJ.

Thank you for your enquiry dated 03 Sep 2018. Please note this letter and information is only being provided in response to a property search and should not be used when carrying out any construction or excavation works.


An assessment has been carried out with respect to Cadent Gas Ltd apparatus. Please note that the plan attached does not show the location of domestic or industrial service pipes but they should be anticipated near to buildings or property.

Based on the information you have provided we have concluded that Cadent Gas Ltd infrastructure **is not Affected**. Therefore, the land which is subject of this enquiry is not subject to the provisions of an Easement or Wayleave agreement with regard to Cadent gas Ltd apparatus. However, there may still be rights reserved for apparatus granted to other utility companies

IMPORTANT NOTE: This response is for the Cadent Gas Ltd networks ONLY. You SHOULD also obtain information of National Grid gas and electricity transmission networks. Please refer to www.utilitysearch.com

For any other enquiries, particularly regarding carrying out any construction activities, you are required to contact our Cadent Plant Protection team in advance of any work at the following address:

Plant Protection
Cadent, Block 1
Brick Kiln Street
Hinckley LE10 0NA
0800 688 588
plantprotection@cadentgas.com

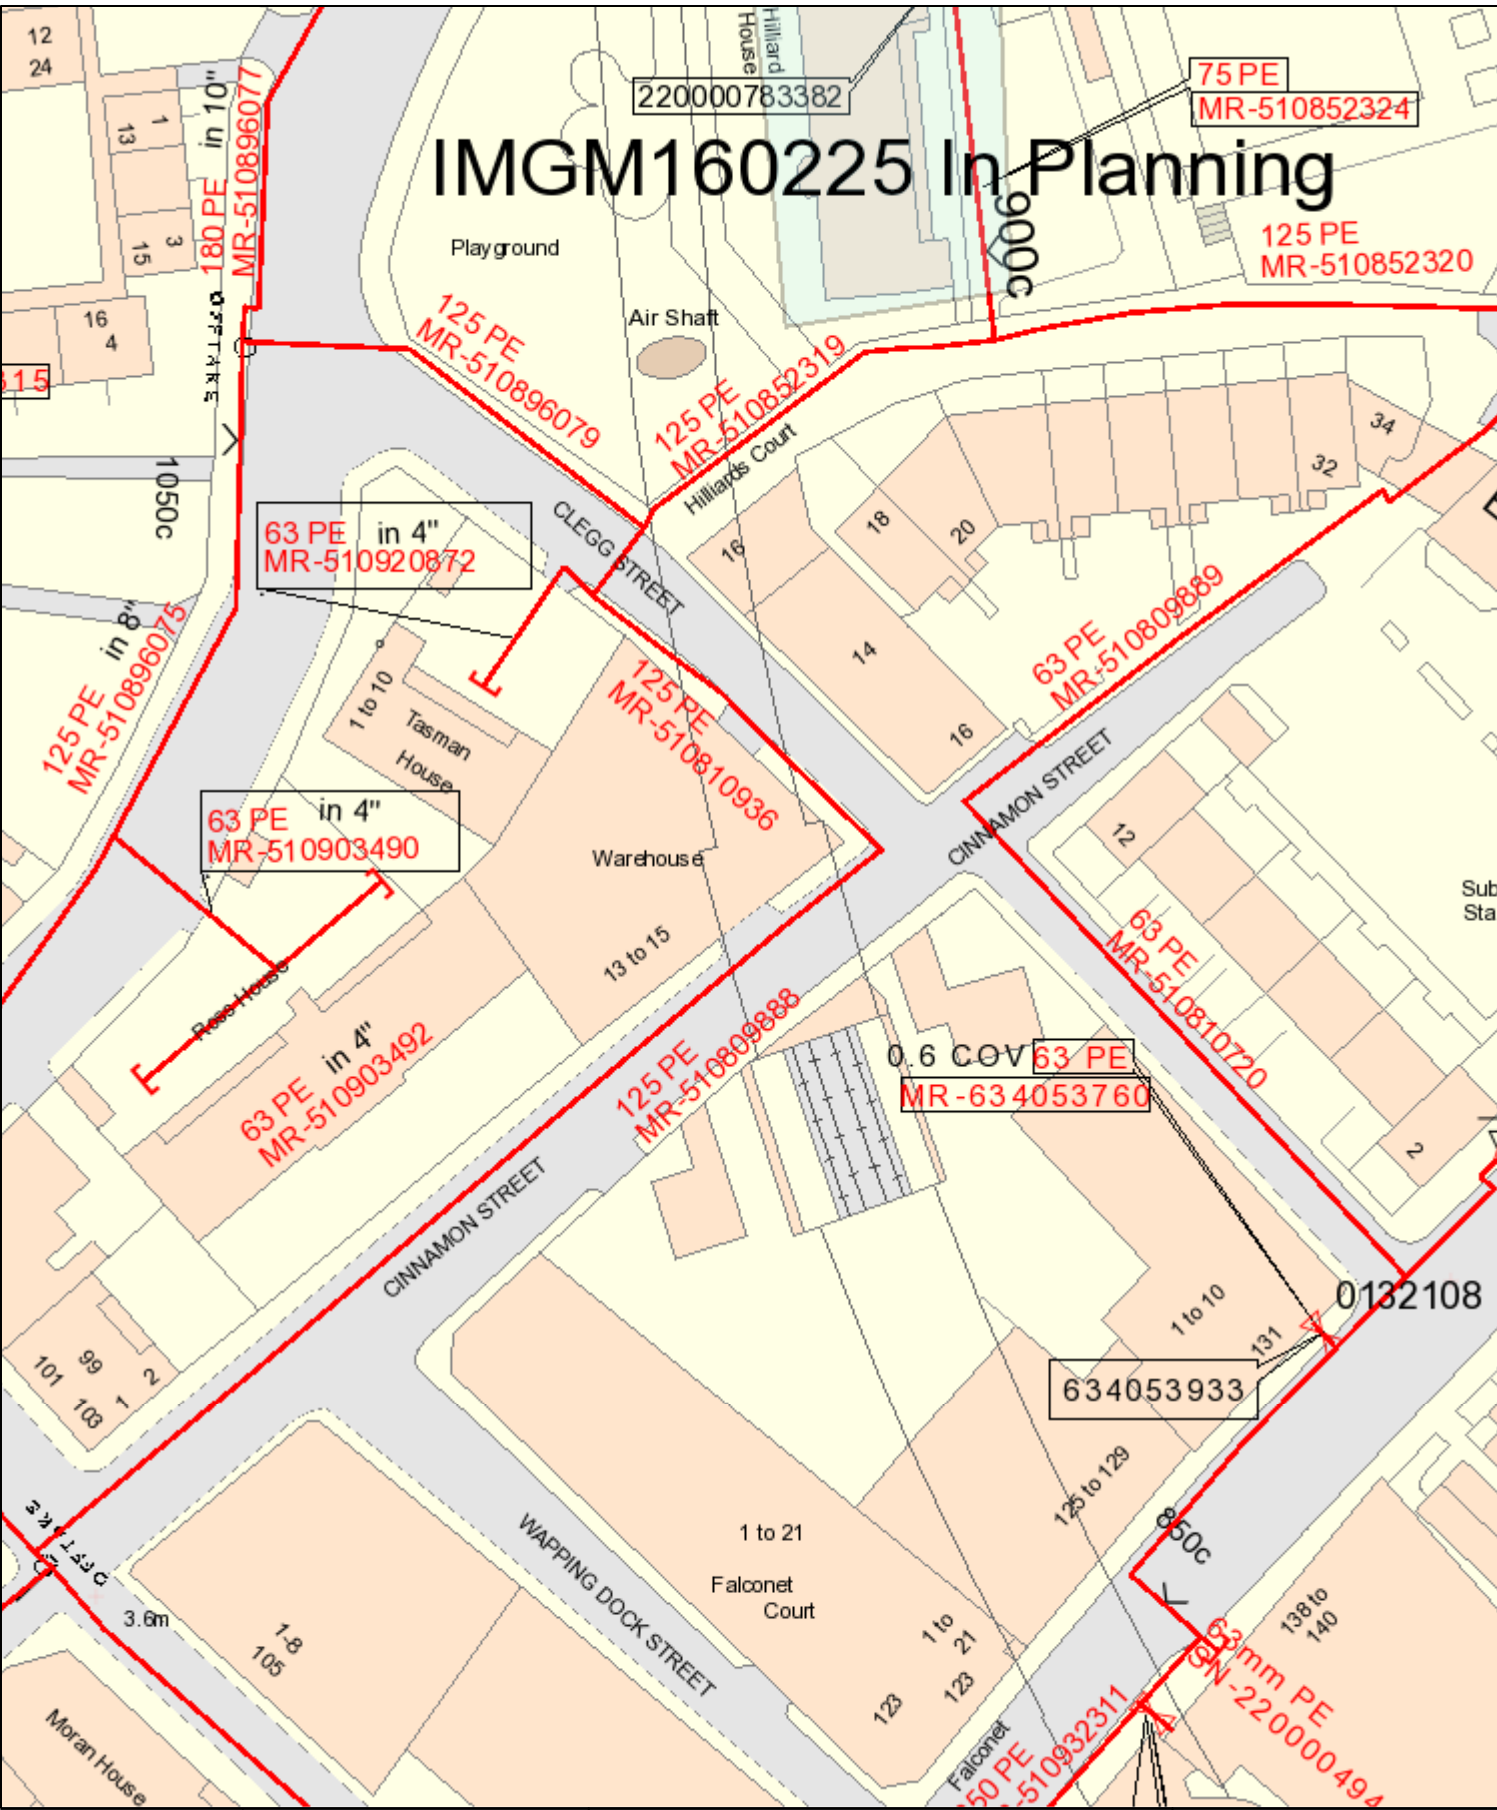

SCALE: 1:625	LP MAINS	<p>This plan shows those pipes owned by Cadent Gas Limited in their role as a Licensed Gas Transporter (GT). Gas pipes owned by other GTs, or otherwise privately owned, may be present in this area. Information with regard to such pipes should be obtained from the relevant owners. The information shown on this plan is given without warranty, the accuracy thereof cannot be guaranteed. Service pipes, valves, syphons, stub connections, etc. are not shown but their presence should be anticipated. No liability of any kind whatsoever is accepted by Cadent Gas Limited or their agents, servants or contractors for any error or omission. Safe digging practices, in accordance with HS(G)47, must be used to verify and establish the actual position of mains, pipes, services and other apparatus on site before any mechanical plant is used. It is your responsibility to ensure that this information is provided to all persons (either direct labour or contractors) working for you on or near gas apparatus. The information included on this plan should not be referred to beyond a period of 28 days from the date of issue.</p>	
USER ID: Natalie.Creane	MP MAINS		
DATE: 9/4/2018	IP MAINS		
NRSWA RESPONSE	LHP MAINS		
MAP REF: TQ3480	NHP MAINS		
CENTRE: 534987,180255	HISTORY MAINS	0.6 COV	<p>This plan is reproduced from or based on the OS map by Cadent Gas Limited, with the sanction of the controller of HM Stationery Office. Crown Copyright Reserved</p>
Some examples of plant items:	OUT OF STANDARD SERVICE	63 PE	
Valve	GTS	MR-634053760	
Depth of Cover	SSNs	MR-510810720	
Syphon	Approximate scale 1:625 printed on A4 Colour Portrait	MR-510932311	
Diameter Change		MR-510932311	
Material Change		MR-510932311	